


NOTES:

1. ALL DRAIN LINES TO HAVE MINIMUM SLOPE OF 1:50.
2. ALL DRAIN BRANCHES TIE-IN TO COLLECTION HEADER AT 45°.
3. THE FINAL PIPE SIZE OF CONSUMERS TO BE CONFIRMED AS PER VENDOR INFORMATION.

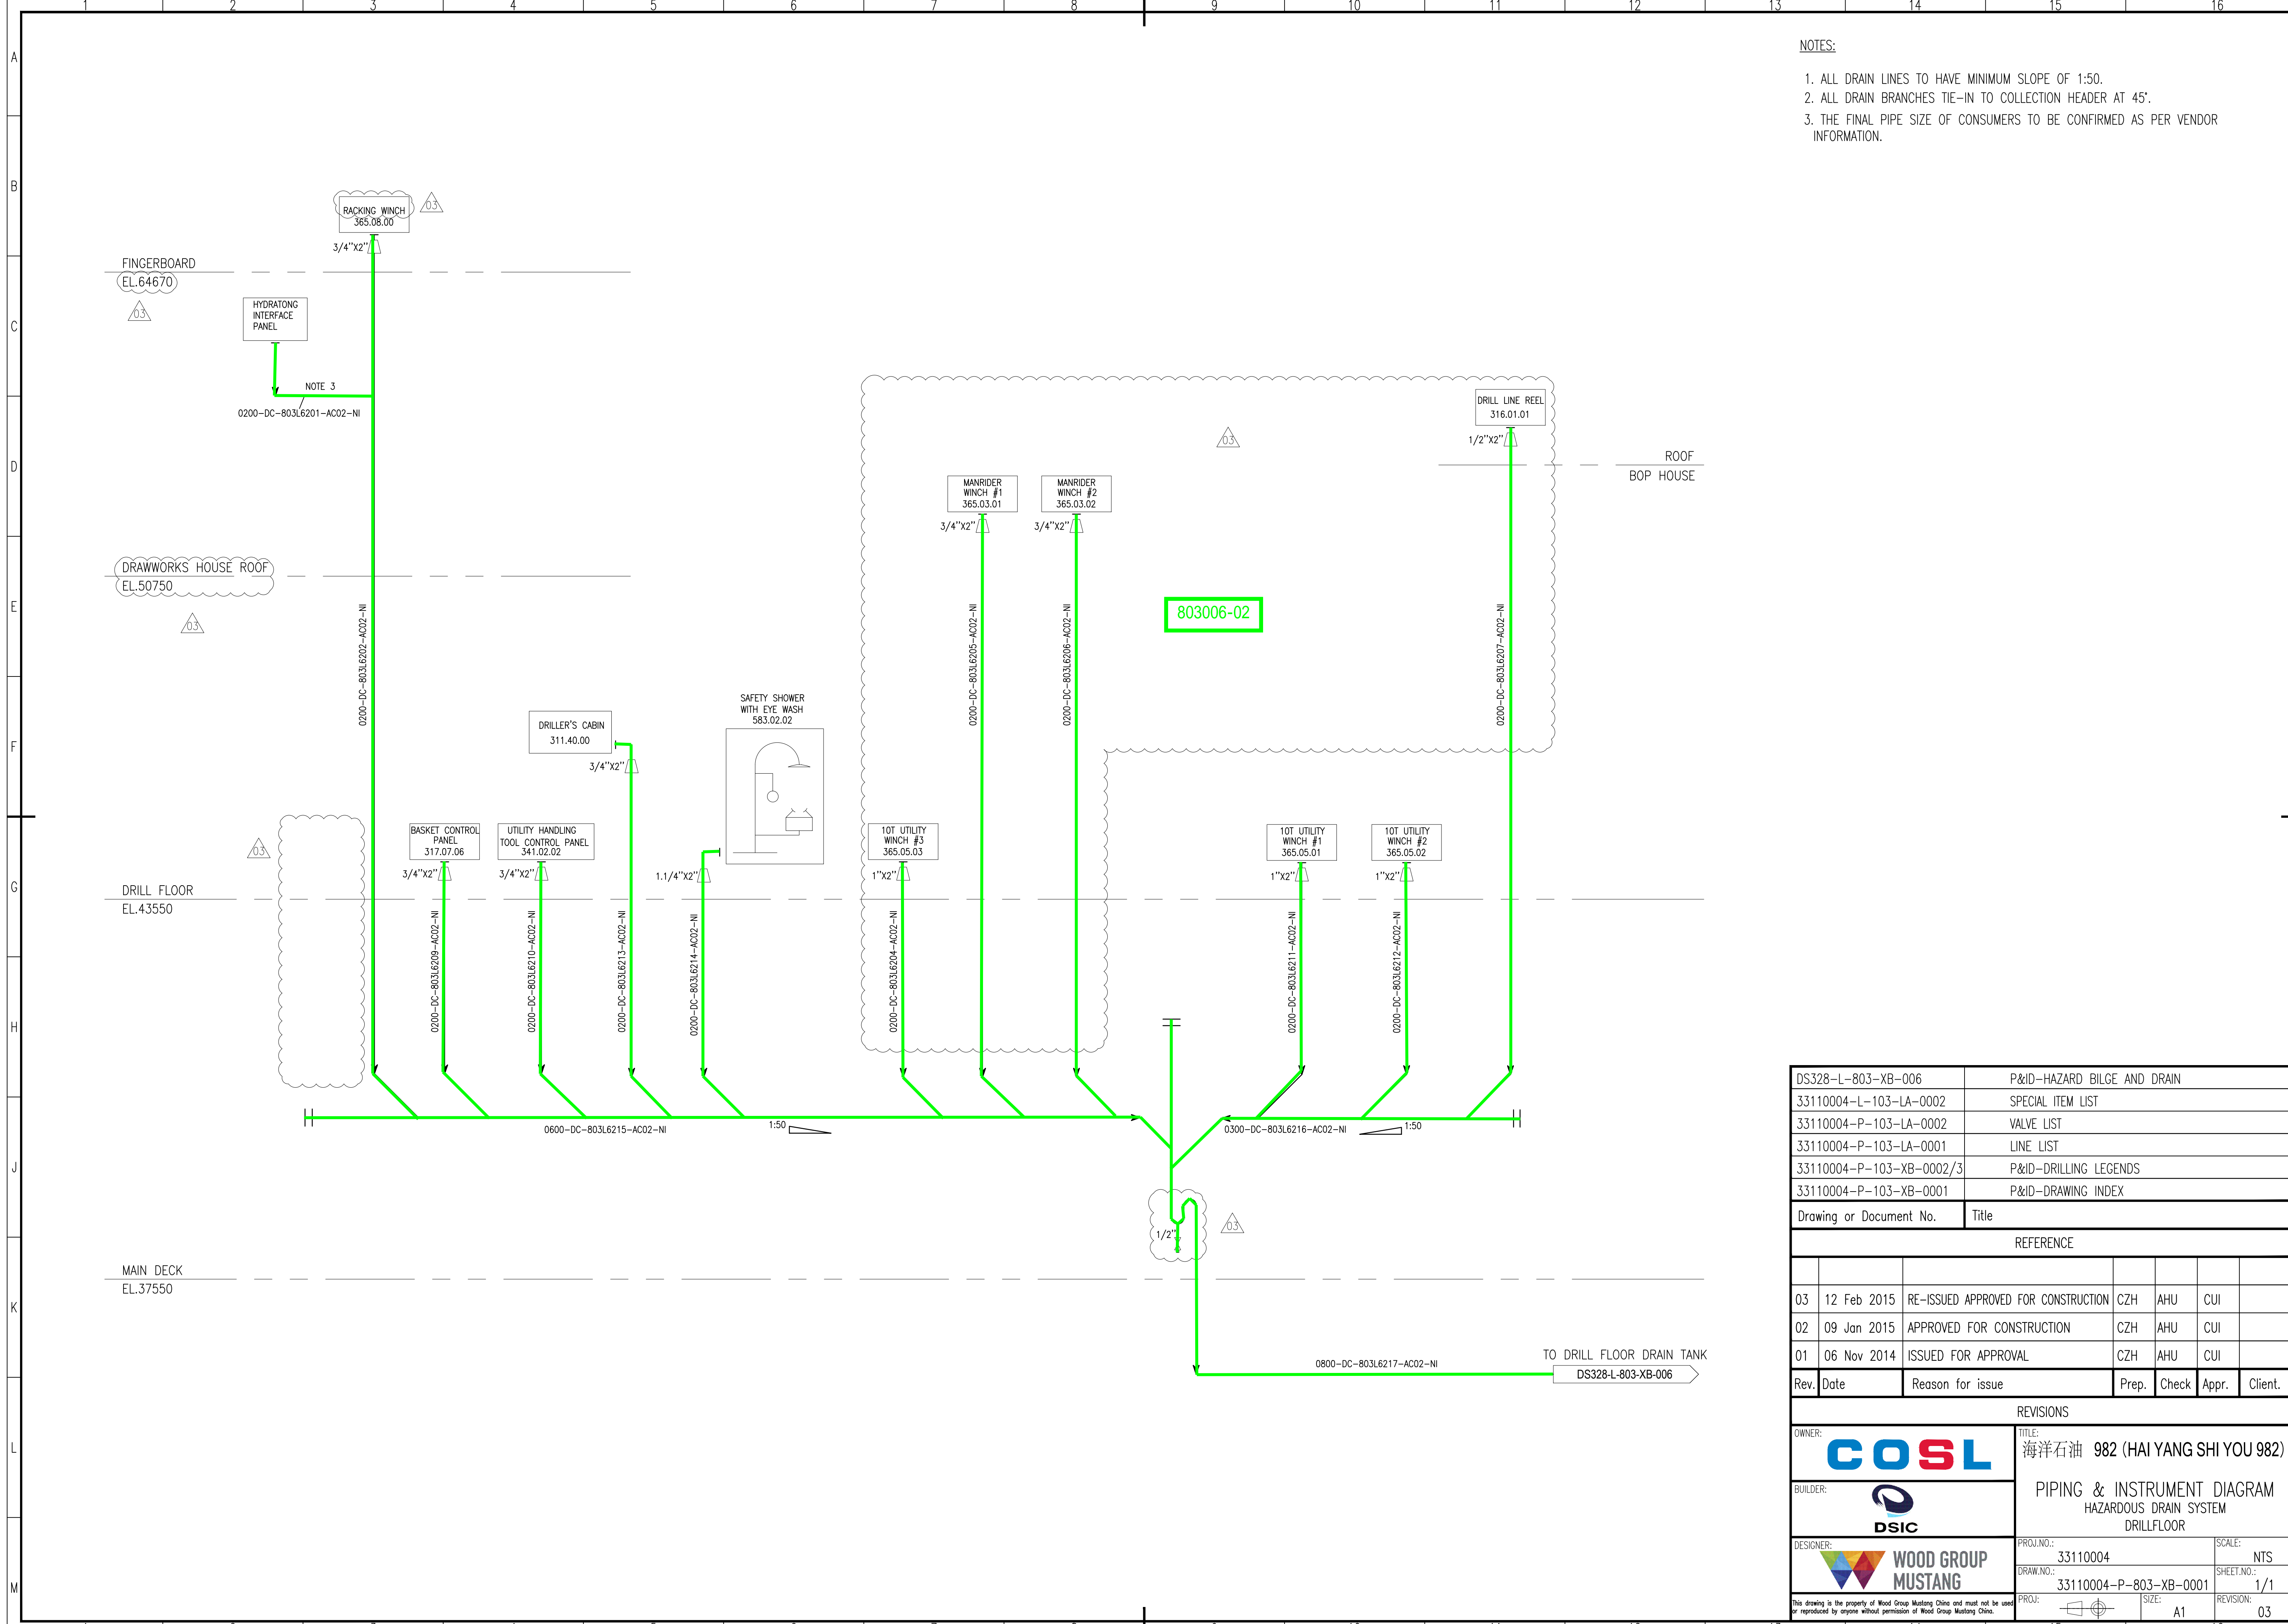

DS328-L-803-XB-006	P&ID-HAZARD BILGE AND DRAIN
33110004-L-103-LA-0002	SPECIAL ITEM LIST
33110004-P-103-LA-0002	VALVE LIST
33110004-P-103-LA-0001	LINE LIST
33110004-P-103-XB-0002/3	P&ID-DRILLING LEGENDS
33110004-P-103-XB-0001	P&ID-DRAWING INDEX
Drawing or Document No.	Title

REFERENCE						
Rev.	Date	Reason for issue	Prep.	Check	Appr.	Client.
03	12 Feb 2015	RE-ISSUED APPROVED FOR CONSTRUCTION	CZH	AHU	CUI	
02	09 Jan 2015	APPROVED FOR CONSTRUCTION	CZH	AHU	CUI	
01	06 Nov 2014	ISSUED FOR APPROVAL	CZH	AHU	CUI	

REVISIONS					
OWNER:	COSL 海洋石油 982 (HAI YANG SHI YOU 982)				
BUILDER:	DSIC				
DESIGNER:	WOOD GROUP MUSTANG				
PROJ. NO.:	33110004	SCALE:	NTS		
DRAW. NO.:	33110004-P-803-XB-0001	SHEET NO.:	1/1		
PROJ.:		SIZE:	A1	REVISION:	03

This drawing is the property of Wood Group Mustang China and must not be used or reproduced by anyone without permission of Wood Group Mustang China.